


— ZONE 1
 — ZONE 2
 — ZONE 3

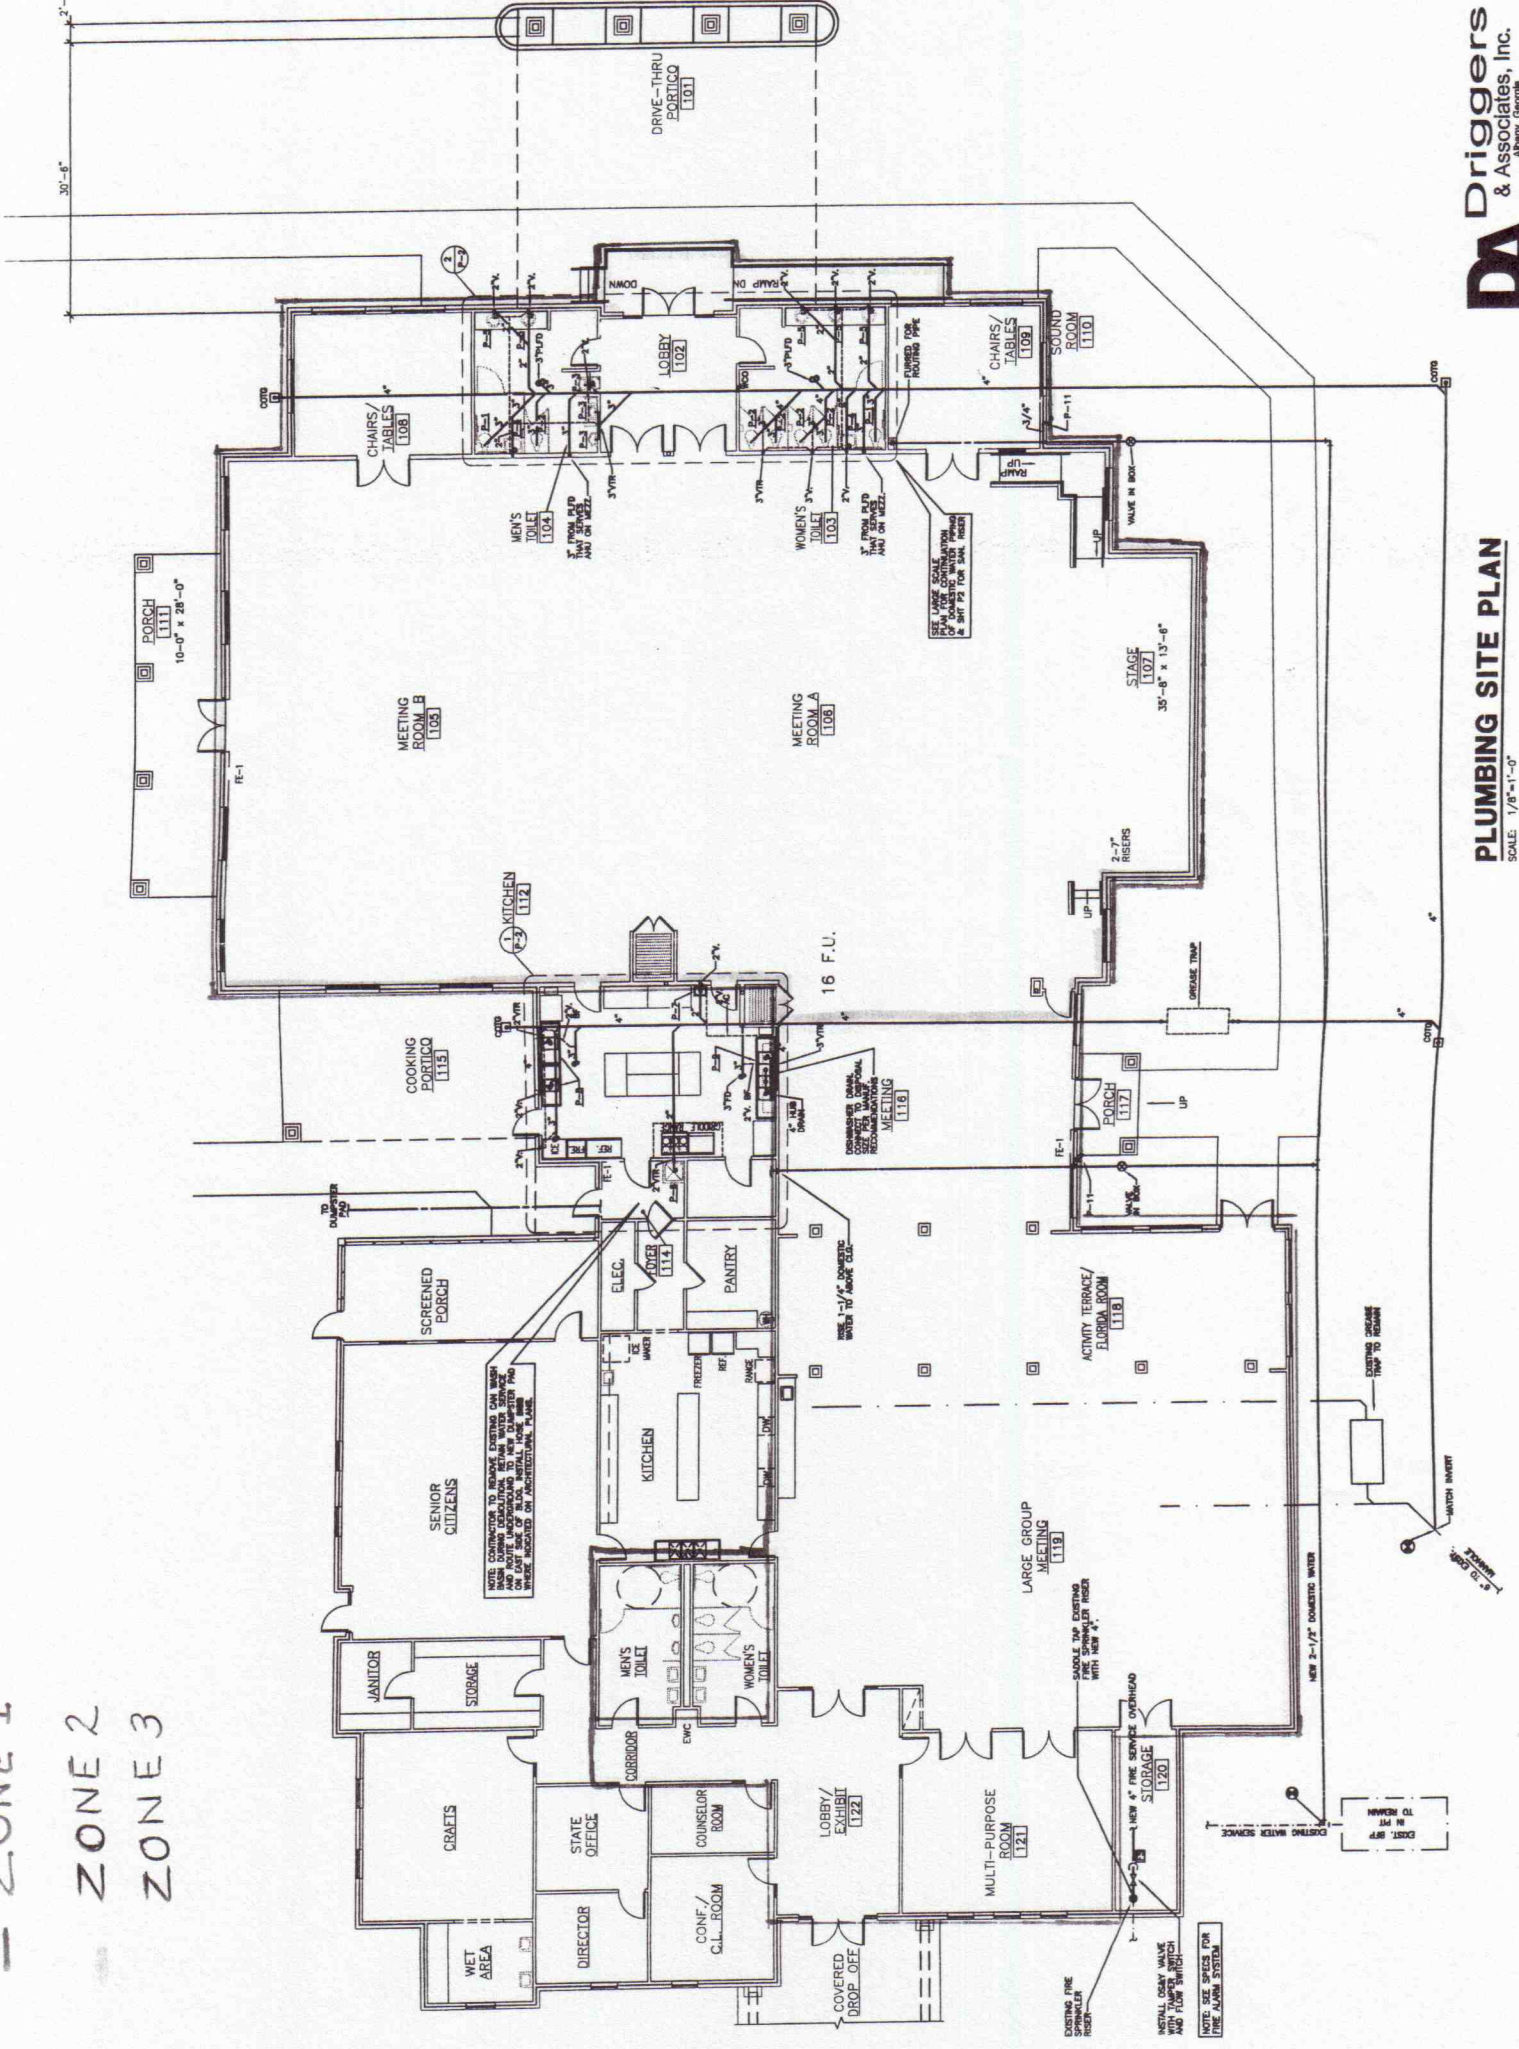

PLUMBING SITE PLAN
 SCALE: 1/8"=1'-0"